



Exhibit: **A-7**

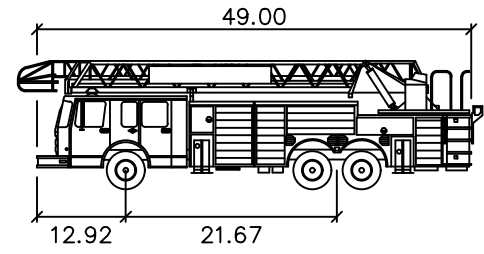

BT Fire Truck


- Width : 8.67
- Track : 8.25
- Lock to Lock Time : 5.0
- Steering Angle : 28.0

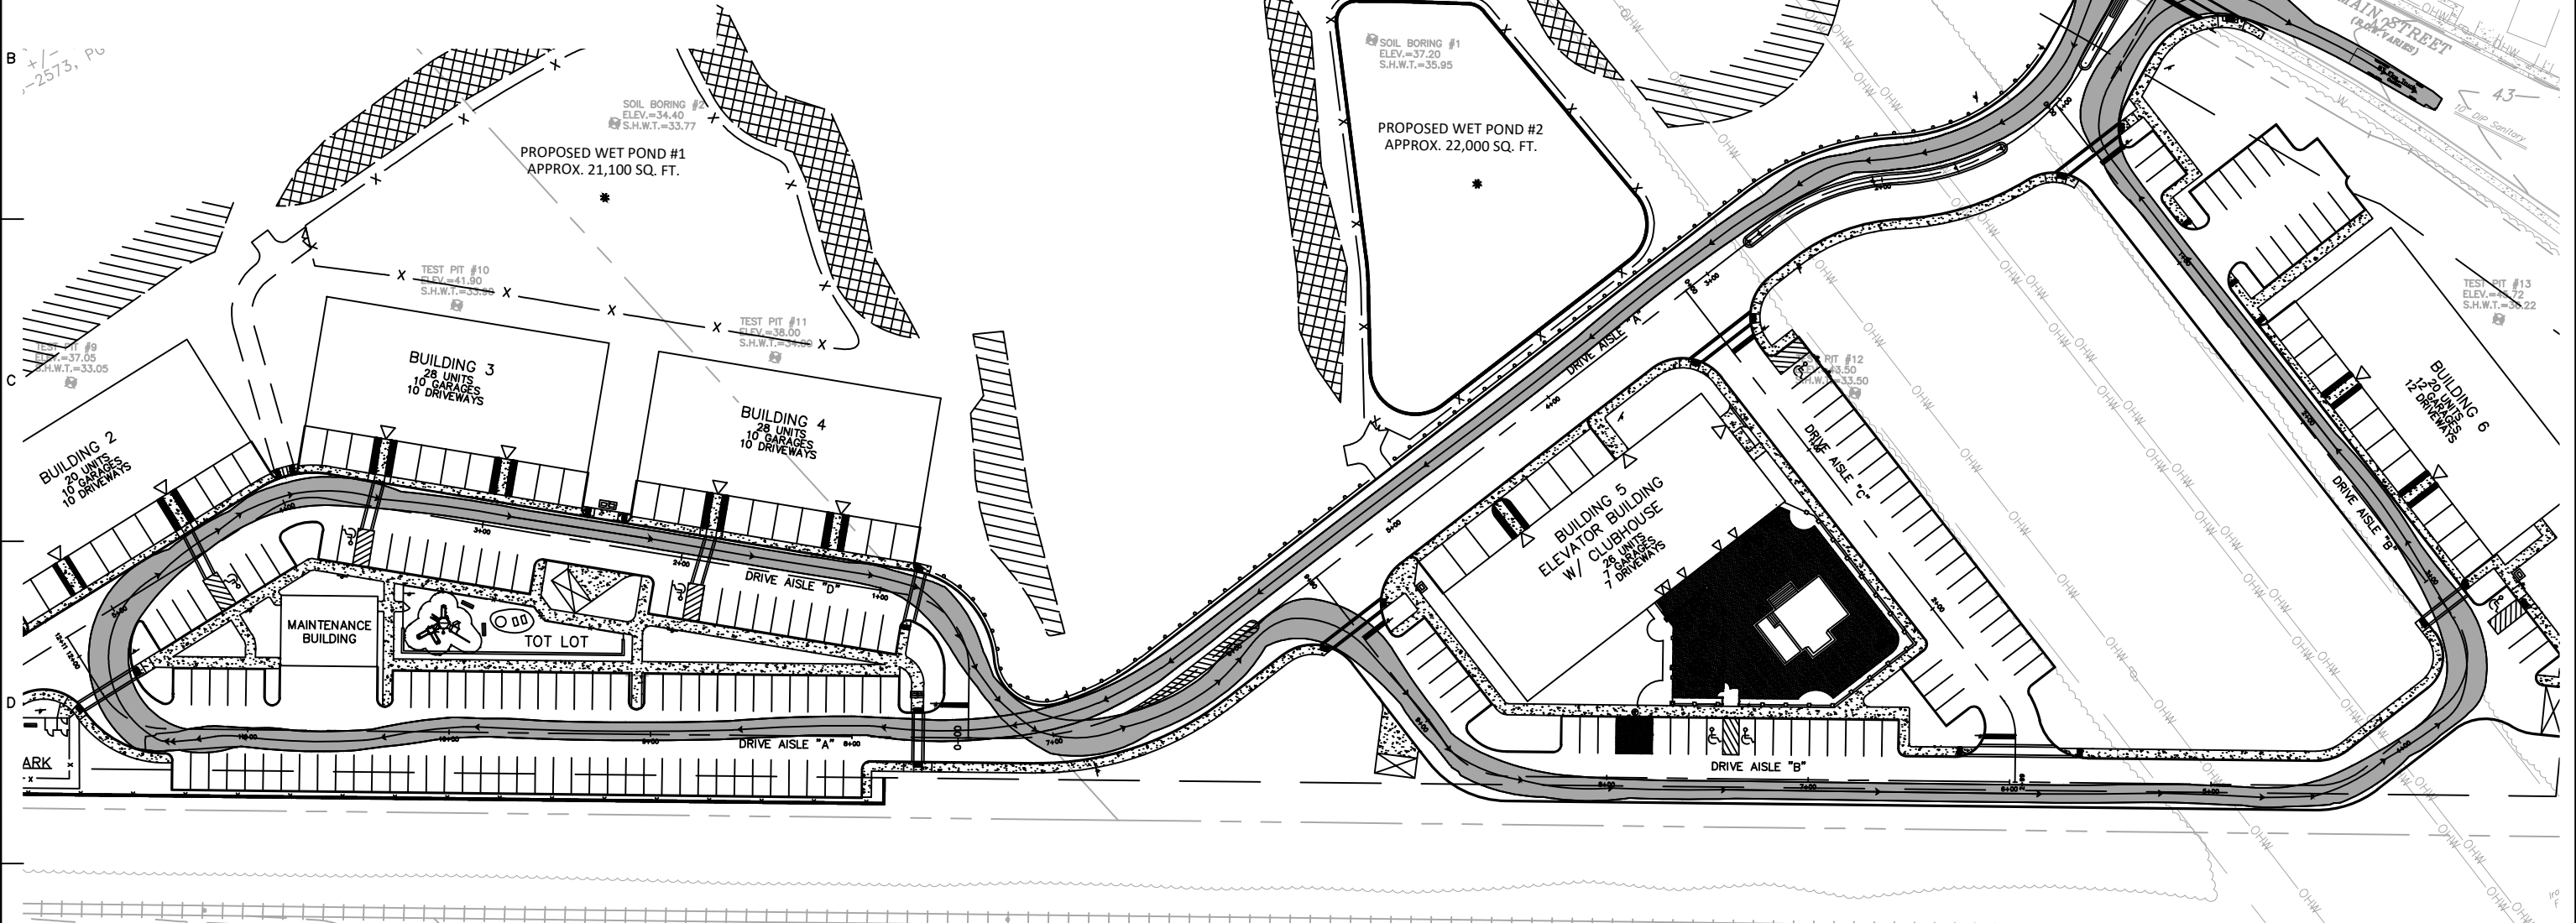

NOTE:
 THIS EXHIBIT PREPARED IN RESPONSE TO CME COMMENT E.2 DATED NOVEMBER 5, 2020. THE FINAL SITE PLAN WILL BE REVISED TO REFLECT THE ADJUSTED DRIVEWAY RADII ON THIS EXHIBIT.

11/20/2020	REVISED CURB RETURN RADII PER CME COMMENT	1
Date	Description	No.

LANGAN Langan Engineering and Environmental Services, Inc. 989 Lenox Drive, Suite 124 Lawrenceville, NJ 08648 T: 609.282.8000 F: 609.282.8001 www.langan.com NJ Certificate of Authorization No.24GA27996400	Project CAMELOT AT ERNSTON ROAD BOROUGH OF SAYERVILLE MIDDLESEX COUNTY NEW JERSEY	Drawing Title TRUCK TURNING EXHIBIT - FIRE TRUCKS		Project No. 130101101 Date 9/30/2020 Drawn By SLH Checked By KAP	Drawing No. EXHIBIT 1 Sheet 1 of 2
		Drawing No. EXHIBIT 1			

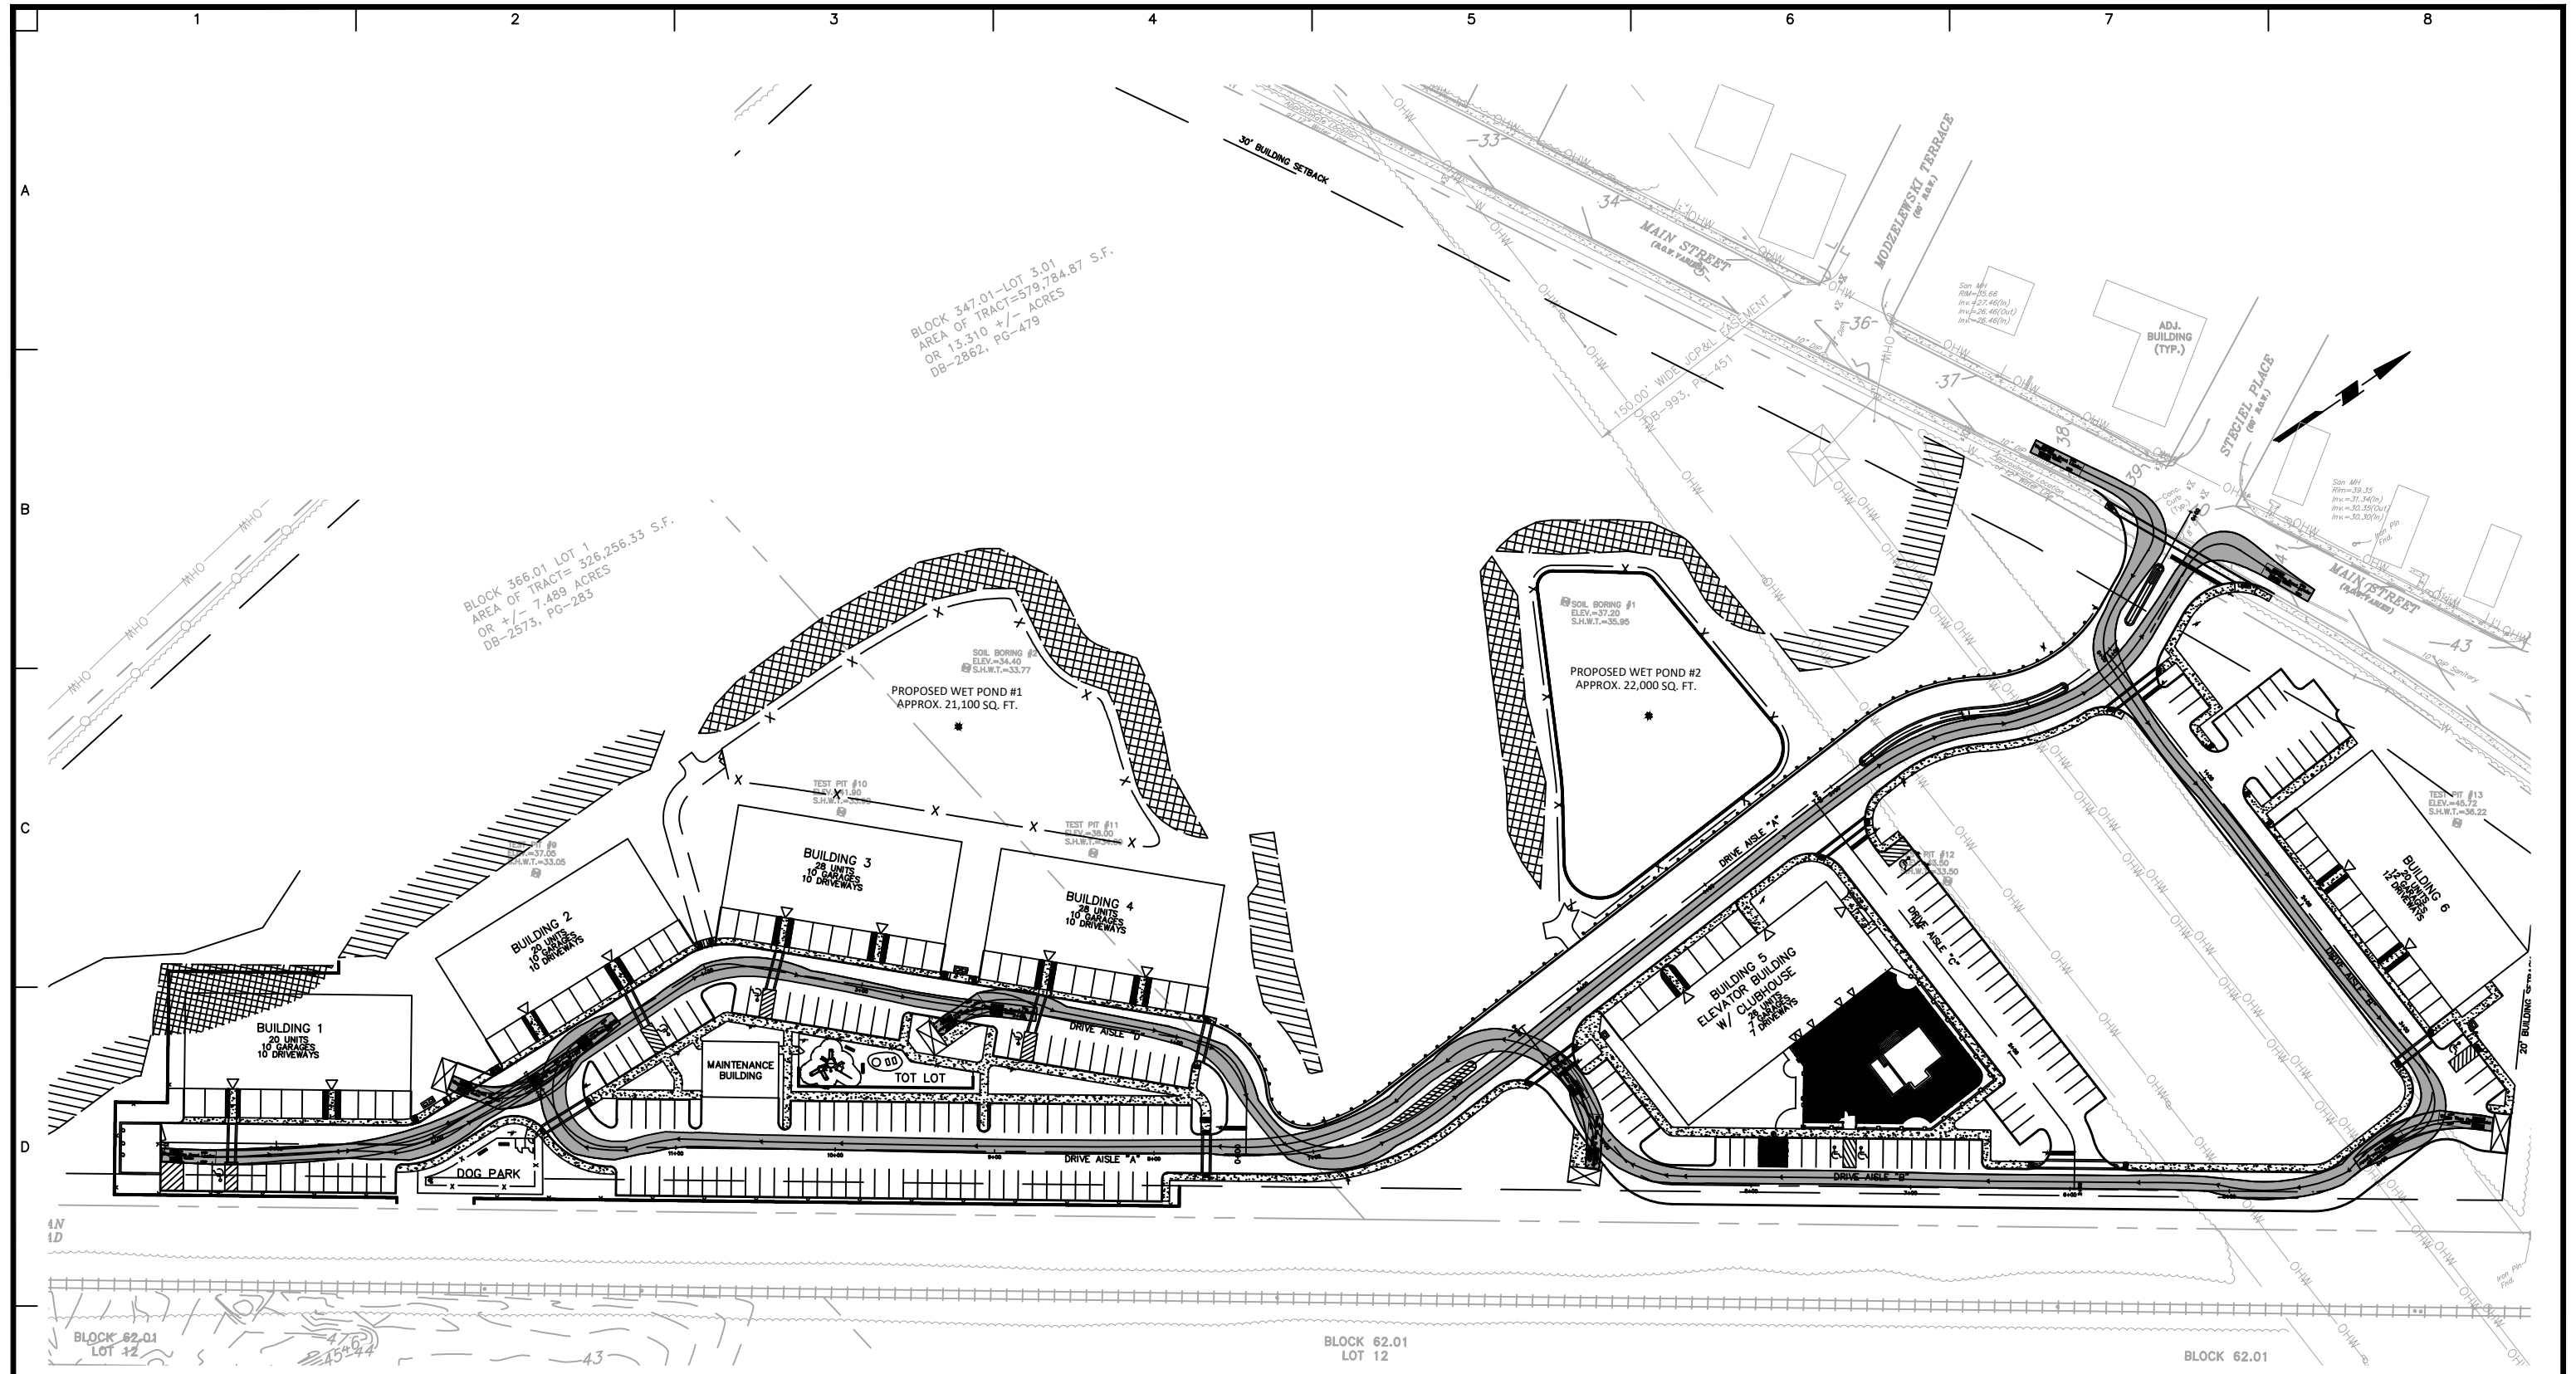

11/20/2020	REVISED CURB RETURN RADII PER CME COMMENT	1
Date	Description	No.

LANGAN Langan Engineering and Environmental Services, Inc. 989 Lenox Drive, Suite 124 Lawrenceville, NJ 08648 T: 609.282.8000 F: 609.282.8001 www.langan.com NJ Certificate of Authorization No.24GA27996400	Project CAMELOT AT ERNSTON ROAD BOROUGH OF SAYERVILLE MIDDLESEX COUNTY NEW JERSEY	Drawing Title		Project No.	Drawing No.	
		TRUCK TURNING EXHIBIT - GARBAGE TRUCKS		130101101	EXHIBIT 2 Sheet 2 of 2	
				Date		9/30/2020
				Drawn By		SLH
		Checked By	KAP			