


FOR ADMINISTRATION BUILDING FLOOR AND LIGHTING PLAN SEE DWG C101, SHEET 2 OF 2

SOLID WASTE DUMPSTERS (SEE NOTE 1)

- NOTES**
- DUMPSTERS SHALL BE FOUR (4) CUBIC YARD CAPACITY FRONT LOAD SLANT TOP CONTAINERS WITH REINFORCED PLASTIC LIDS. FLOORS SHALL BE 10 GAUGE STEEL AND WALLS SHALL BE 12 GAUGE.

- LIGHTING LEGEND**
- FL** 45 W LED FLOOD LIGHT, 3" ABOVE ROOF
 - PL** 300 W LED DUAL POLE MOUNT FLOOD LIGHT
 - RL** 200 W LED ROADWAY LIGHT

SITE PARKING AND LIGHTING PLAN
SCALE 1"=30'

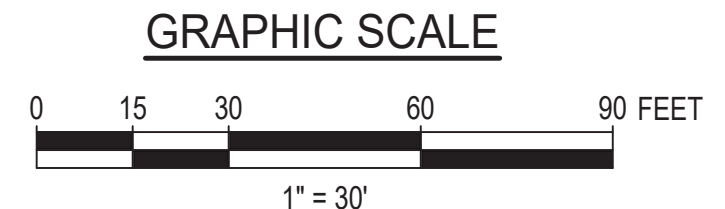

MARTIN C BALLOD
STATE OF NEW JERSEY
MARTIN C. BALLOD
No. GE30509
LICENSED PROFESSIONAL ENGINEER

Digitally signed by Martin Ballod
Date: 2020.08.26 15:31:20 -04'00'
NEW JERSEY PROFESSIONAL ENGINEER NO. GE30509

C-101-SHT 1.DWG

INTER-DISCIPLINE REVIEW						
DISC	ARCH	CIVIL	ELECT	I&C	MECH	STRUCT
DATE	-	-	-	-	-	-
INIT	-	-	-	-	-	-

REV	ISSUED FOR PERMITTING	DATE	DRN	DSGN	CKD	APPD	REFERENCE DRAWINGS
0	ISSUED FOR PERMITTING	8/26/2020	AMW	MB	MB	KC	

DSGN	MB	8/26/2020
DRN	AMW	8/26/2020
CKD	MB	8/26/2020
SCALE:	AS SHOWN	



GENON ENERGY SAYREVILLE STATION		JOB NUMBER	REV
ADMINISTRATION BUILDING RELOCATION PROJECT, SAYREVILLE, NJ		163426 WSV #1	0
SUPPLEMENTAL SITE PLAN PARKING AND LIGHTING PLAN		DRAWING NUMBER	
PROPOSED LOT A: BLOCK 174, PORTION OF LOT 1, BLOCK 176 & LOT 6		C-101	1 OF 2