


- GENERAL LIGHTING NOTES:**
- EXTERIOR BUILDING MOUNTED LIGHT FIXTURES SHALL PROVIDE A MINIMUM OF 2 FOOT-CANDLES AROUND BUILDING. FIXTURES SHALL BE 45 W LED FLOOD LIGHTS MOUNTED 3" ABOVE ROOF.
 - ALL BUILDING MOUNTED LIGHT FIXTURES SHALL BE INSTALLED 18'-0" ABOVE FINISHED GRADE.
 - POLE MOUNTED LIGHTS SHALL BE INSTALLED 20'-0" ABOVE GRADE AND ROADWAY. LIGHT FIXTURES SHALL PROVIDE A MINIMUM OF 2 FOOT-CANDLES. POLE MOUNTED FLOOD LIGHTS SHALL BE 300 W LED DUAL FIXTURES. FIXTURES FOR ROADWAYS SHALL BE 200 W LED COBRA HEAD LED UNITS.

- LIGHTING LEGEND**
- FL 45 W LED FLOOD LIGHT, 3" ABOVE ROOF
 - PL 300 W LED DUAL POLE MOUNT FLOOD LIGHT
 - RL 200 W LED ROADWAY LIGHT

ADMINISTRATION BUILDING FLOOR AND LIGHTING PLAN
 BUILDING FLOOR AREA = 2390 SQUARE FEET
 SCALE 1/4" = 1'-0"

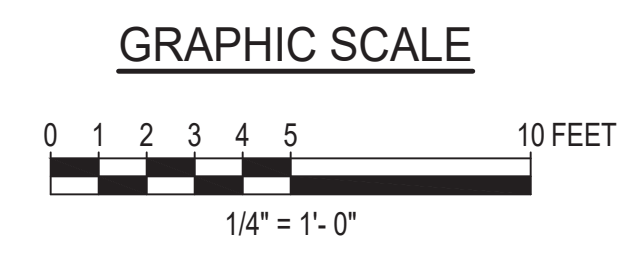

MARTIN C BALLOD

Digitally signed
 by Martin Ballood
 Date: 2020.08.26
 15:52:40 -04'00'
 NEW JERSEY PROFESSIONAL
 ENGINEER NO. GE30509


C-101-SHT 2.DWG

THIS DRAWING WAS PREPARED BY POWER ENGINEERS, INC. FOR A SPECIFIC PROJECT, TAKING INTO CONSIDERATION THE SPECIFIC AND UNIQUE REQUIREMENTS OF THE PROJECT. REUSE OF THIS DRAWING OR ANY INFORMATION CONTAINED IN THIS DRAWING FOR ANY PURPOSE IS PROHIBITED UNLESS WRITTEN PERMISSION FROM BOTH POWER AND POWER'S CLIENT IS GRANTED.

INTER-DISCIPLINE REVIEW						
DISC	ARCH	CIVIL	ELECT	I&C	MECH	STRUCT
DATE	-	-	-	-	-	-
INIT	-	-	-	-	-	-

REV	ISSUED FOR PERMITTING	DATE	DRN	DSGN	CKD	APPD	REFERENCE DRAWINGS
0	ISSUED FOR PERMITTING	8/26/2020	AMW	MB	MB	KC	
	REVISIONS	DATE	DRN	DSGN	CKD	APPD	REFERENCE DRAWINGS

DSGN	MB	8/26/2020
DRN	AMW	8/26/2020
CKD	MB	8/26/2020
SCALE:	AS SHOWN	
FOR 24x36 DWG ONLY		

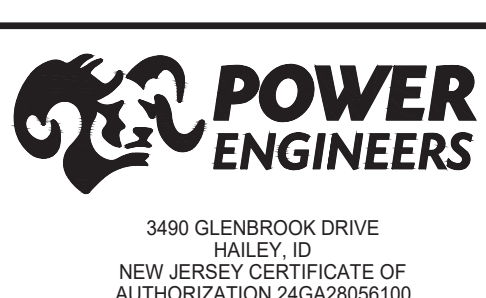

GENON ENERGY SAYREVILLE STATION
 ADMINISTRATION BUILDING
 RELOCATION PROJECT, SAYREVILLE, NJ
 SUPPLEMENTAL SITE PLAN
 ADMINISTRATION BUILDING - FLOOR AND LIGHTING PLAN
 PROPOSED LOT A: BLOCK 174, PORTION OF LOT 1, BLOCK 176 & LOT 6

JOB NUMBER	163426 WSV #1	REV	0
DRAWING NUMBER	C-101	2 OF 2	